

FLOATERS (L&R) 1-16" 2000W FRESNEL ON ROLLING STAND, BLACK RISERS, BARN DOORS & COLOR FRAME CASE

500 O.I.C 4-8' 9 1/2" 500W PAR 64 SPOT X-RAY #4-10" 750W BEAM PROJ.

300 O.I.C 4-8' 12 1/2" PIPE #9: 4-10' 0" 15LT. 300W PAR 56 MED. FI. X-RAY

1 2 3 4 BOOM #4 (L&R): 4-16" 1500W BEAM PROJ.

PIPE #8: EXISTING BORDERLIGHT #4

300 O.I.C 4-8' 12 1/2" PIPE #7: 4-10' 0" 15LT. 300W PAR 56 SPOT X-RAY

PIPE #6: 8-10" 750W BEAM PROJ.

1 2 3 4 BOOM #3 (L&R): 4-16" 1500W BEAM PROJ.

PIPE #5: 4-10' 0" 15LT. 300W PAR 56 SPOT X-RAY

OK 3-9' 12 1/2" 500W PAR 64 SPOT X-RAY # 8-10" 750W BEAM PROJ.

1 2 3 4 BOOM #2 (L&R): 4-16" 1500W BEAM PROJ.

PIPE #3: 12-6" 750W ELLIPSOIDAL SPOTS

1 2 3 4 BOOM #1 (L&R): 4-16" 1500W BEAM PROJ.

PIPE #2: EXISTING BORDERLIGHT #1










TORMENTOR (L&R): 8-8" 1000W ELLIPSOIDAL SPOTS

EXISTING BORDERLIGHT #1

PIPE #1: 20-6" 750W ELLIPSOIDAL SPOTS

BALCONY RAIL: 8-8" 1000W ELLIPSOIDAL SPOTS

BOX BOOM (L&R): 6-8" 1000W ELLIPSOIDAL SPOTS

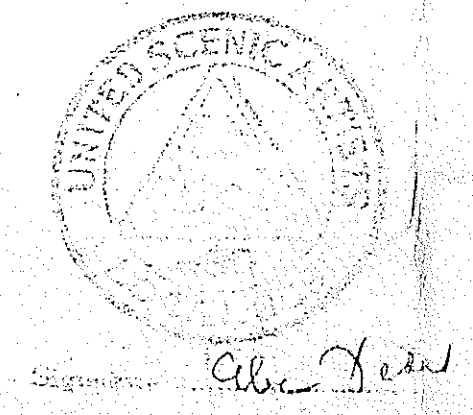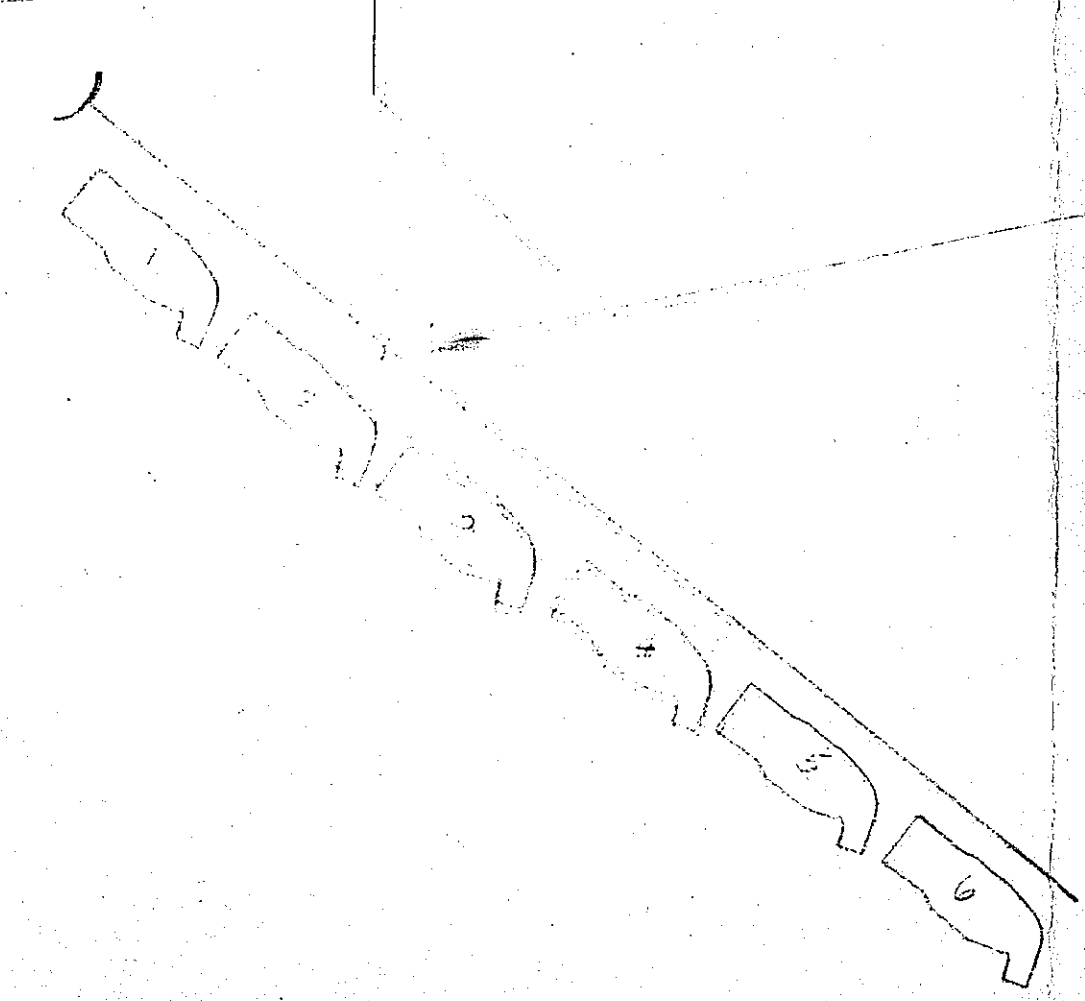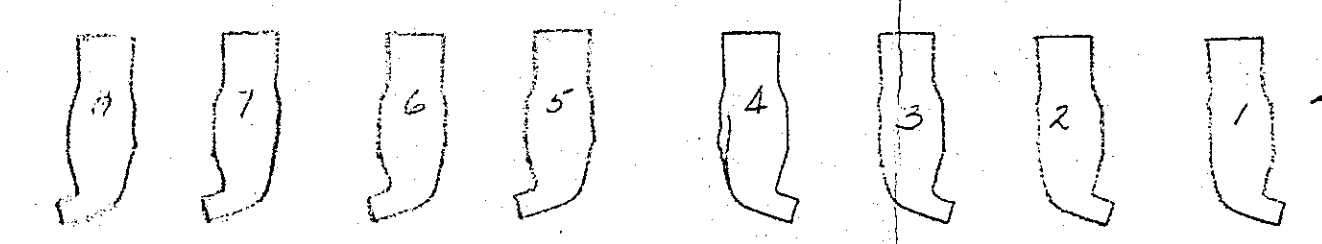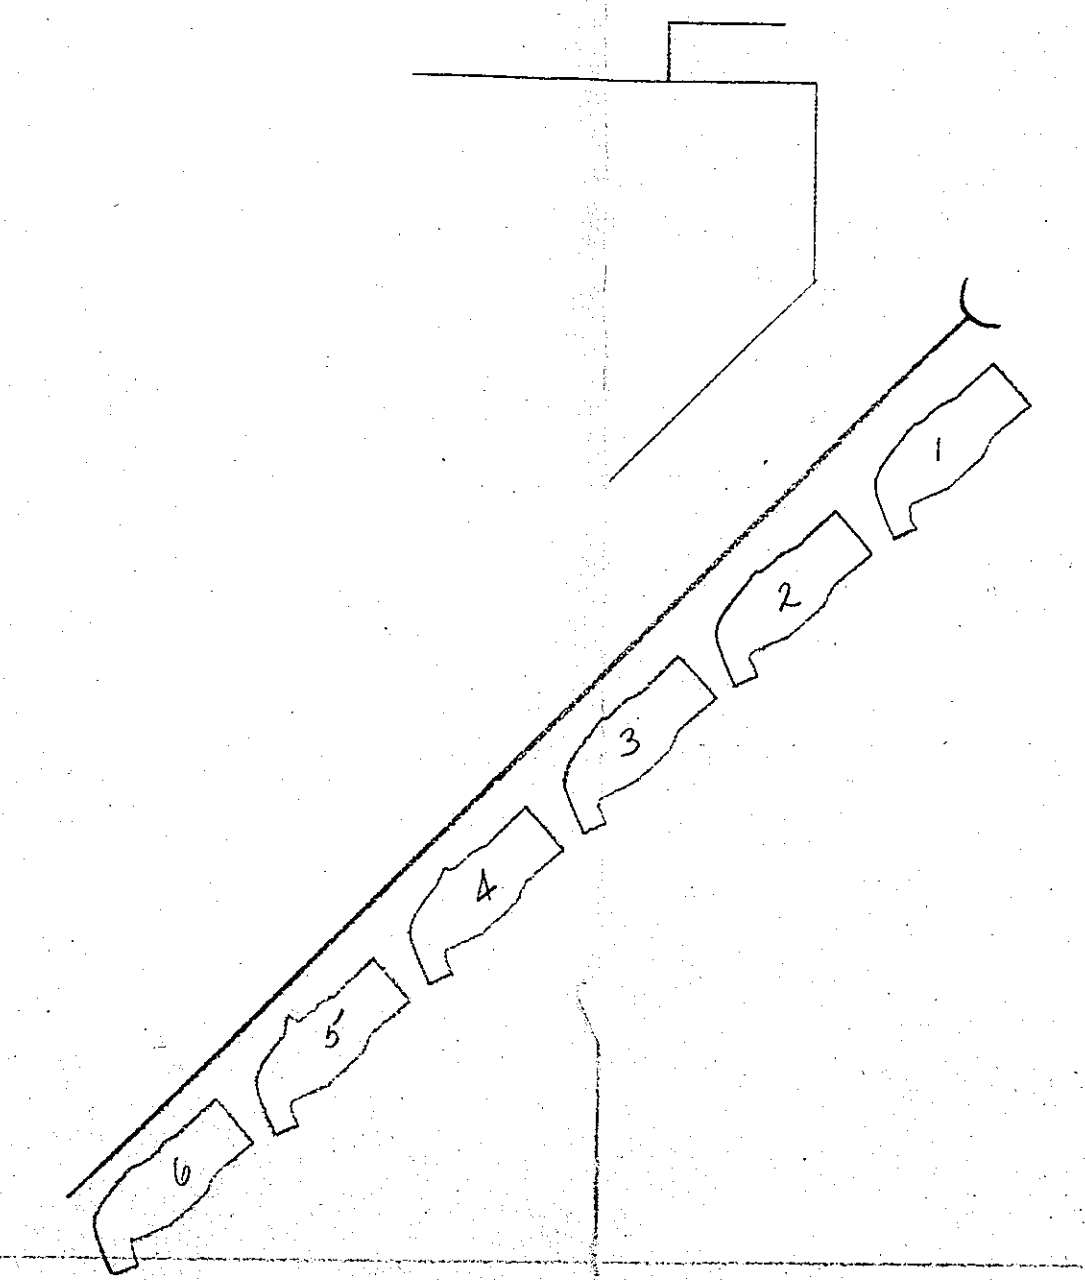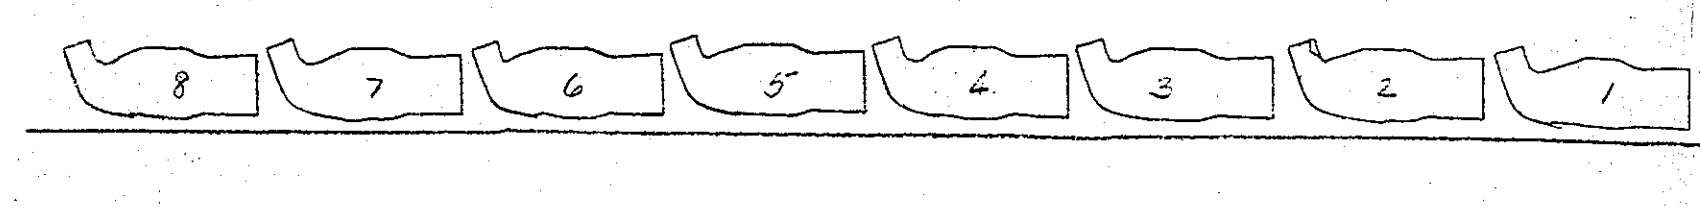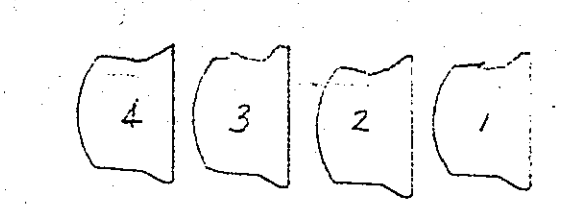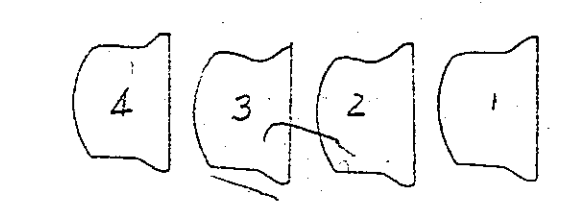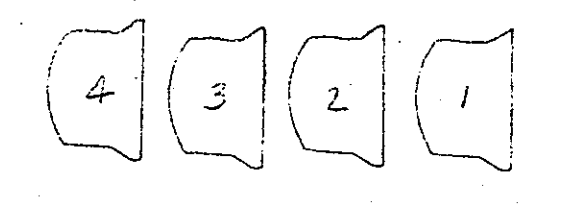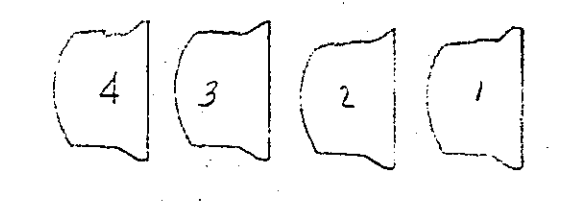

REV.	DATE	DESCRIPTION
LIGHTING BY FEDER		
15 WEST 38 STREET, NEW YORK 18, N. Y.		
JOB	"MY FAIR LADY"	JOB NUMBER
TITLE	CITY CENTER PRODUCTION	
DWG.	LIGHTING PLAN	DWG. NO.
TITLE	PLAN	
DRAWN BY:	A.H.F.	SCALE: 1/2" = 1'-0"
CHECKED BY:		DATE: MAY 1 1966